

Job Name: 26-1000P2 Clark Distributing New HQ - Site Structures
Job Location: Bowling Green, KY
Contractor: Scotty's Contracting & Stone, LLC

Plant: Beaver Dam
8/11/2026 3:45:04 PM

Tech: S. Felletter
PC: M. Sullivan




Structure ID: HDW 2

P1 HWSF24F


24" - HW SLOPED & FLARED w/FLAT BOTTOM F/F

DIMENSIONS									
PPE Ø	A	B	C	D	E	F	G	H	WEIGHT
24"	3'-6"	4'-4"	2'-10"	8"	5'-0"	4"	2'-10"	6'-0"	3,711 LBS.


"A"-ANCHOR LIFTING SYSTEM
FOR PLANT & FIELD HANDLING.

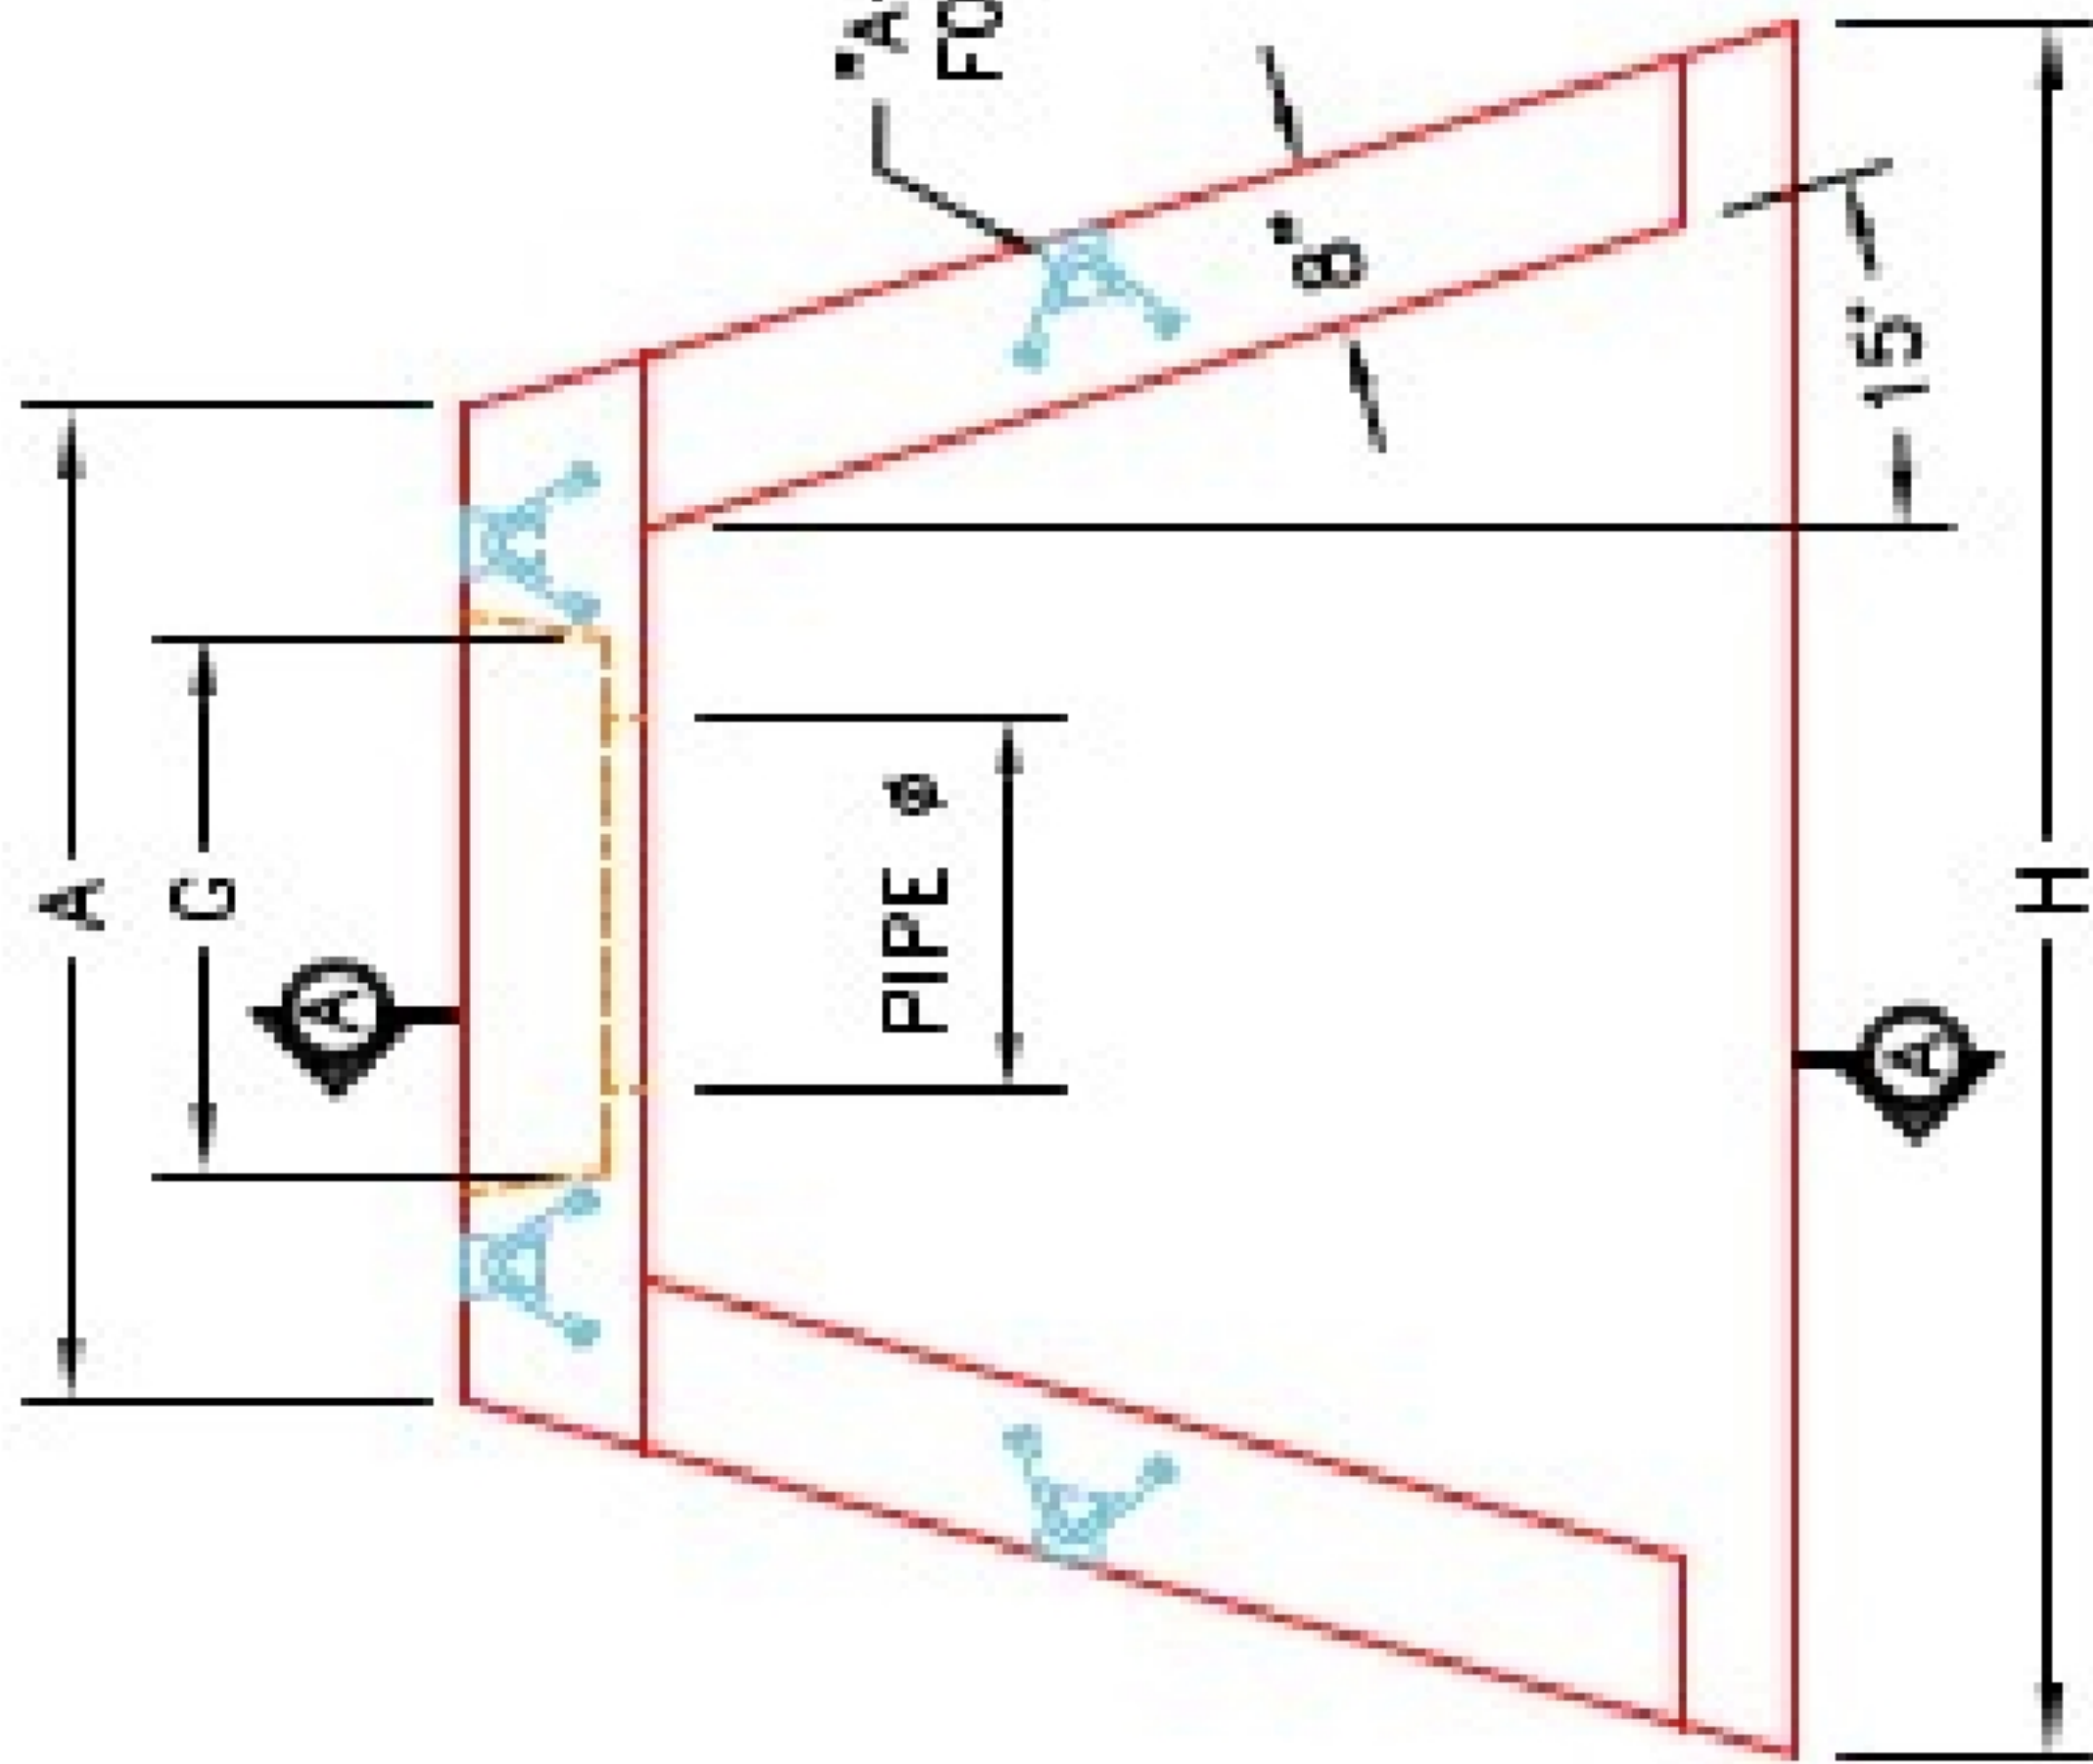


PLAN VIEW

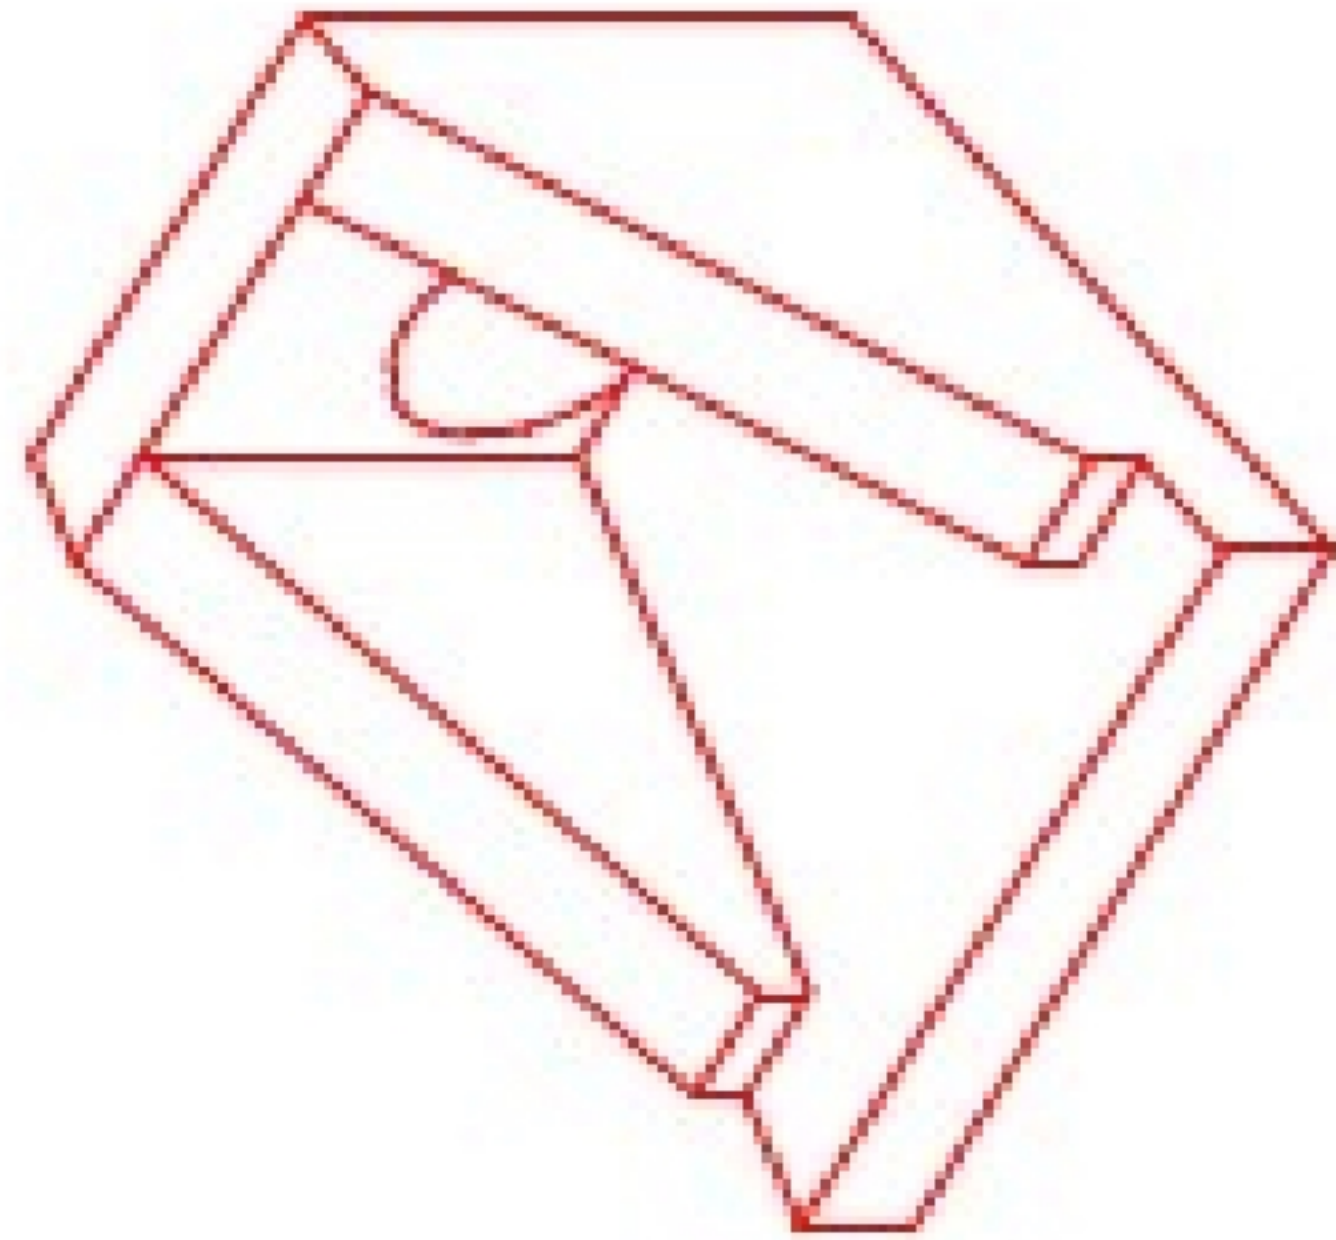

ISOMETRIC VIEW

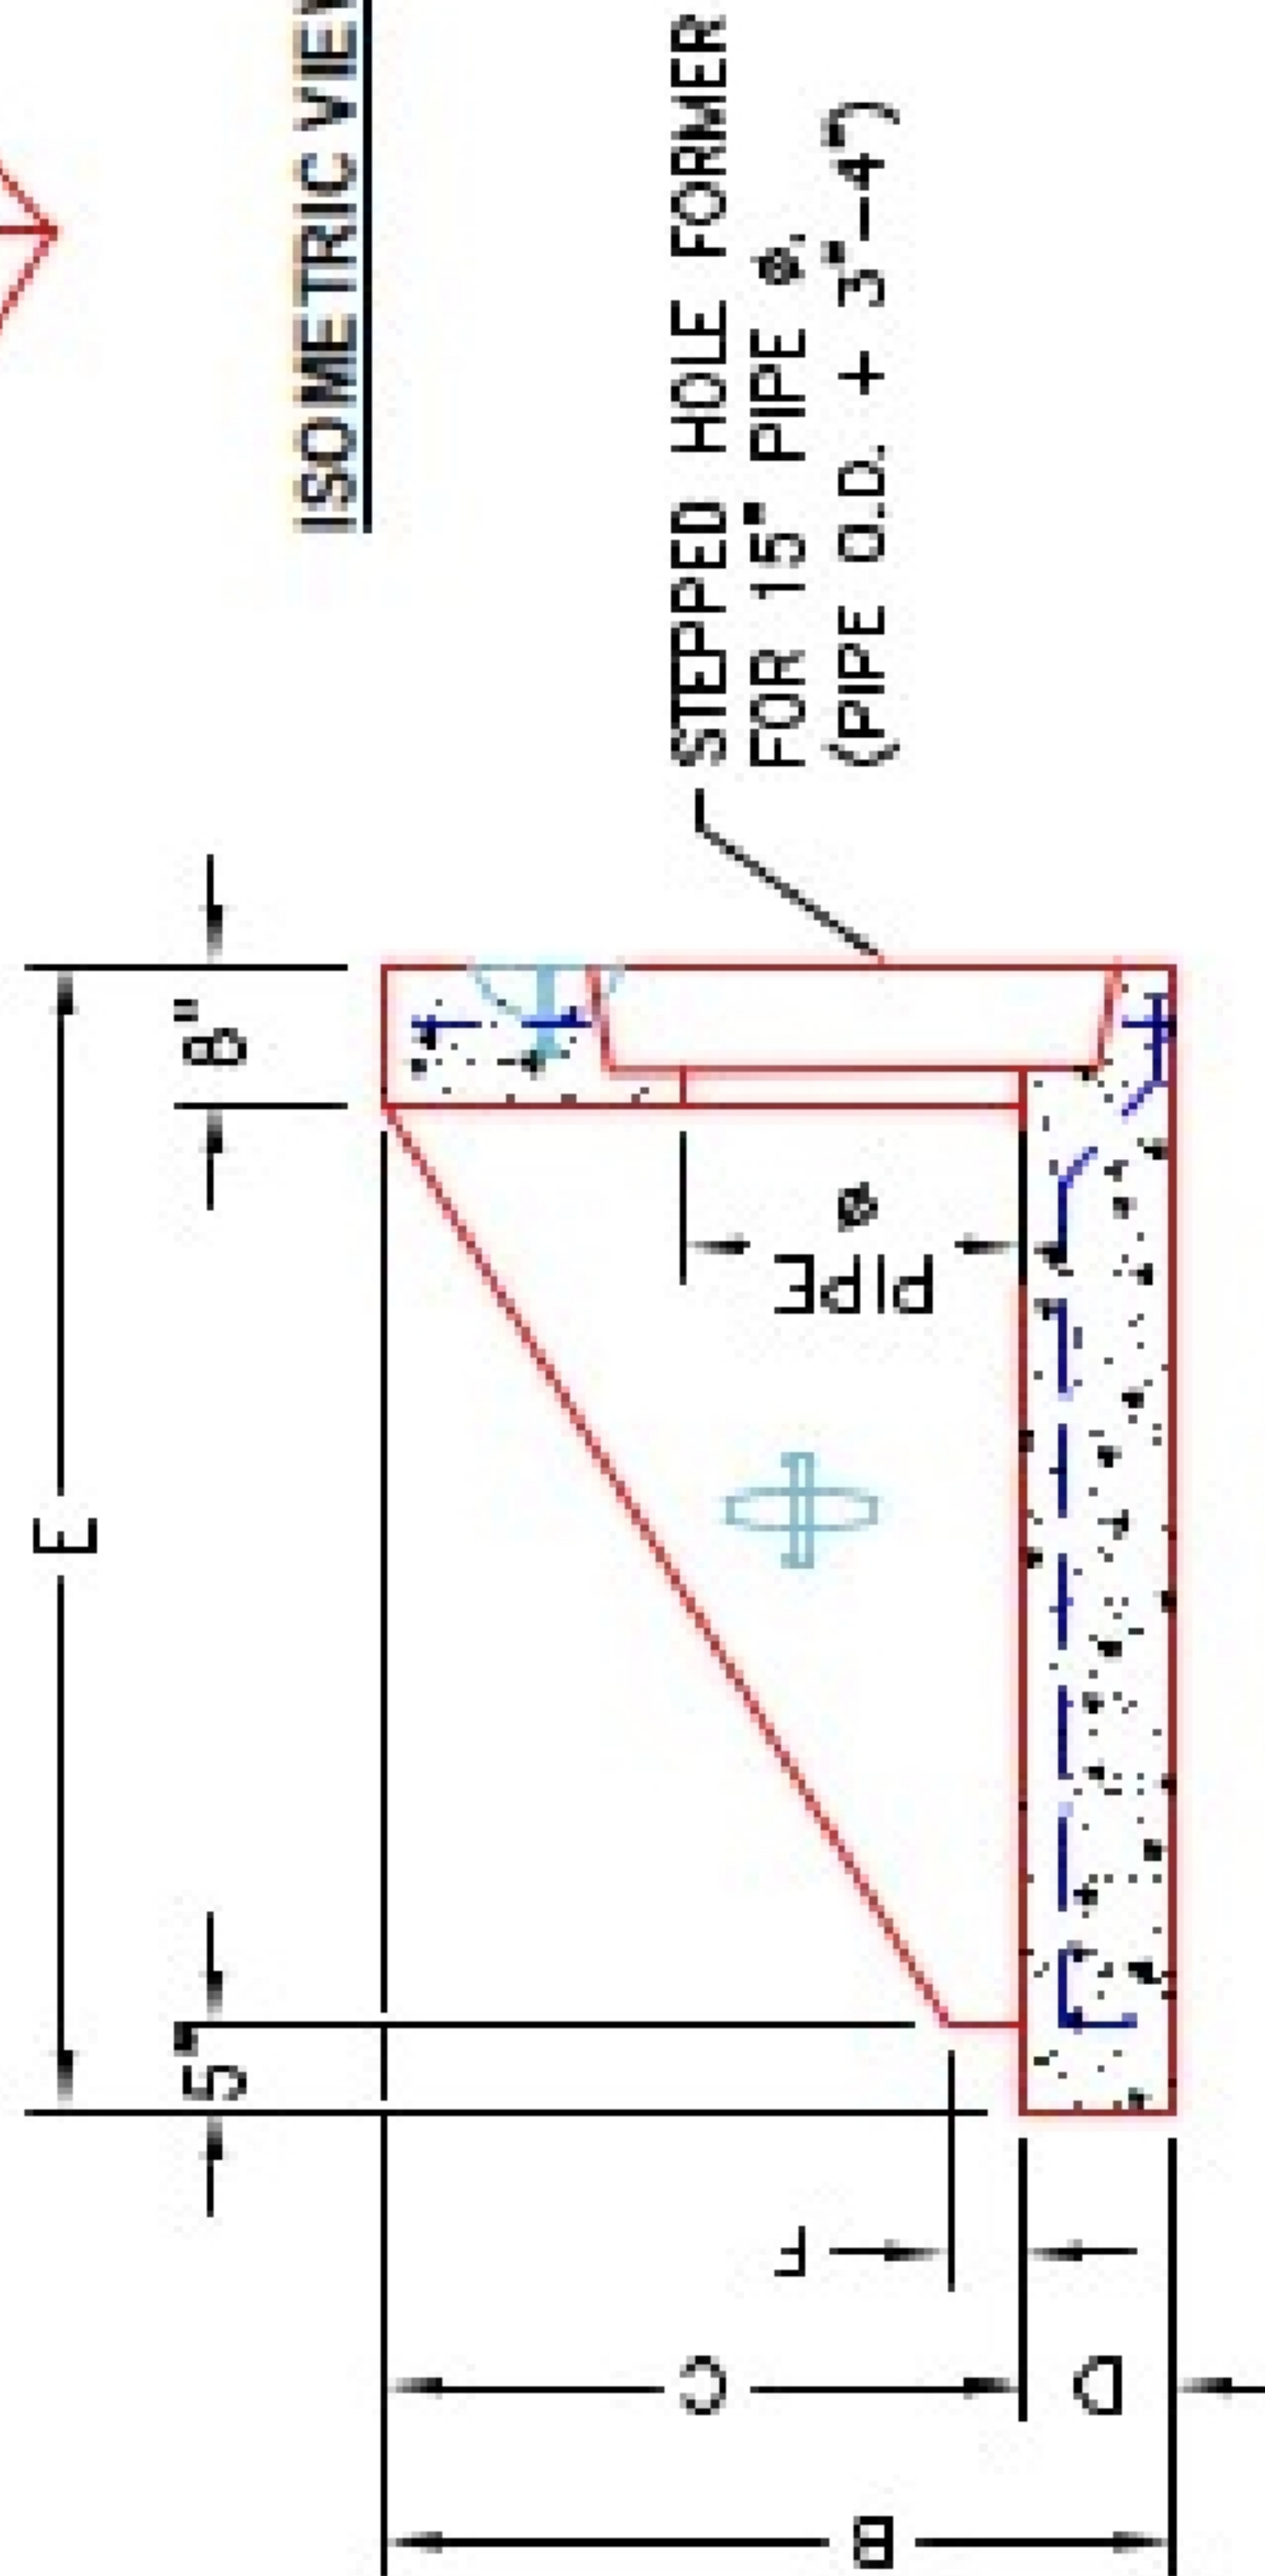

SECTION A-A

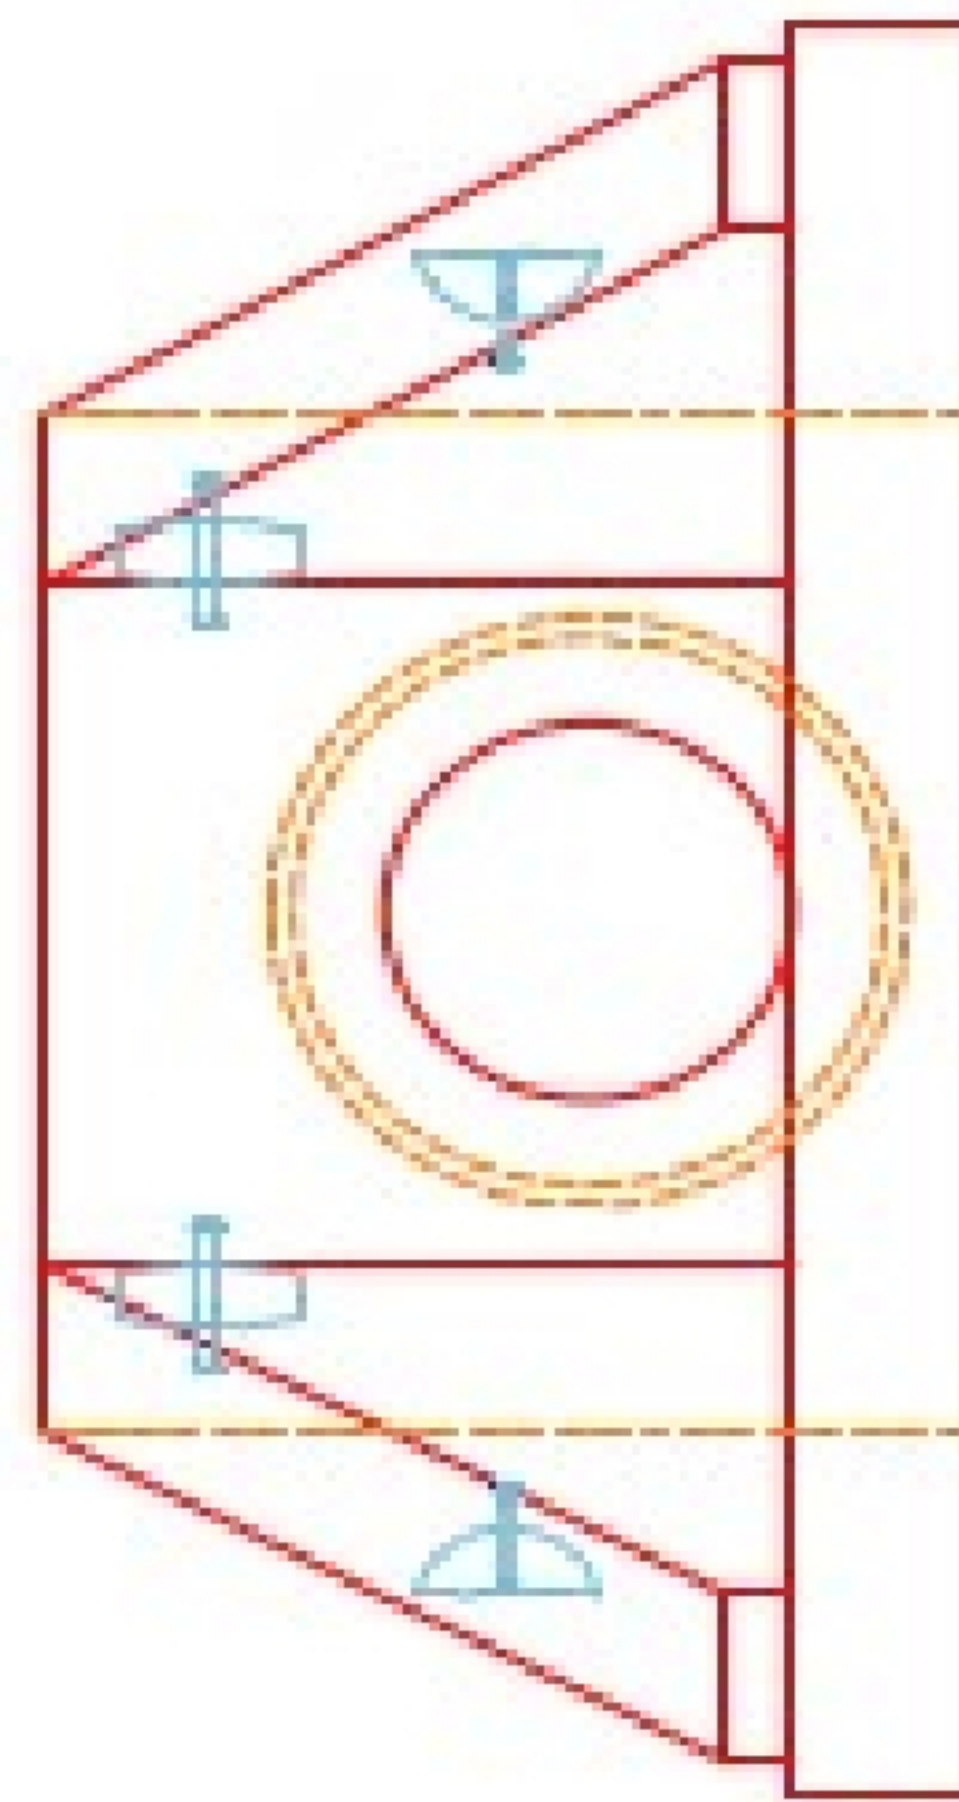

FRONT ELEVATION

NOTES:

1. CONCRETE: KYTC APPROVED.
2. REINFORCING: #4 BAR @ 12" C/C E.W.-GRADE 60, (WITH 2" CONCRETE COVER MINIMUM)
3. REINFORCING BARS TO BE TACK WELDED OR TIED.
4. PIPE AND LIFTING ANCHOR POCKETS TO BE GROUTED WITH KYTC APPROVED NON-SHRINK GROUT.
5. DRAWING TO BE USED IN CONJUNCTION WITH KYTC STD. DRAWING RDH-020-03 AND THE STANDARD SPECIFICATIONS FOR ROAD AND BRIDGE CONSTRUCTION.
6. 3/4" CHAMFER ON ALL EXPOSED EDGES.
7. PREFORMED STEPPED HOLE SIZED AS PER O.D. OF PIPE + 3"-4".



INFRASTRUCTURE PRECAST, INC. 981 WEST 7TH ST., BEAVER DAM, KY 40006 PHONE: (270) 363-2288 FAX: (270) 368-7624			
KYTC 24" SLOPED & FLARED HEADWALL w/ FLAT BOTTOM			
DRAWING NO. HWSF24F	DATE: 8-23-25		
DESIGNED BY: J.B. ROSS, P.E.	DRAWN BY: J. CORPUS		
WEB: WWW.IPCASTING.COM	SCALE: NTS		