

Job Name: 26-1000P2 Clark Distributing New HQ - Site Structures
Job Location: Bowling Green, KY
Contractor: Scotty's Contracting & Stone, LLC

Plant: Beaver Dam

Tech: S. Felletter

8/11/2026 3:45:03 PM

PC: M. Sullivan




Structure ID: HDW 9

P1 HWSF15F


15" - HW SLOPED & FLARED w/FLAT BOTTOM F/F

DIMENSIONS									
PIPE Ø	A	B	C	D	E	F	G	H	WEIGHT
15"	2'-0"	2'-0"	2'-0"	8"	4'-0"	3"	1'-10"	4'-9"	2,610 LBS.


"A"-ANCHOR LIFTING SYSTEM
FOR PLANT & FIELD HANDLING.

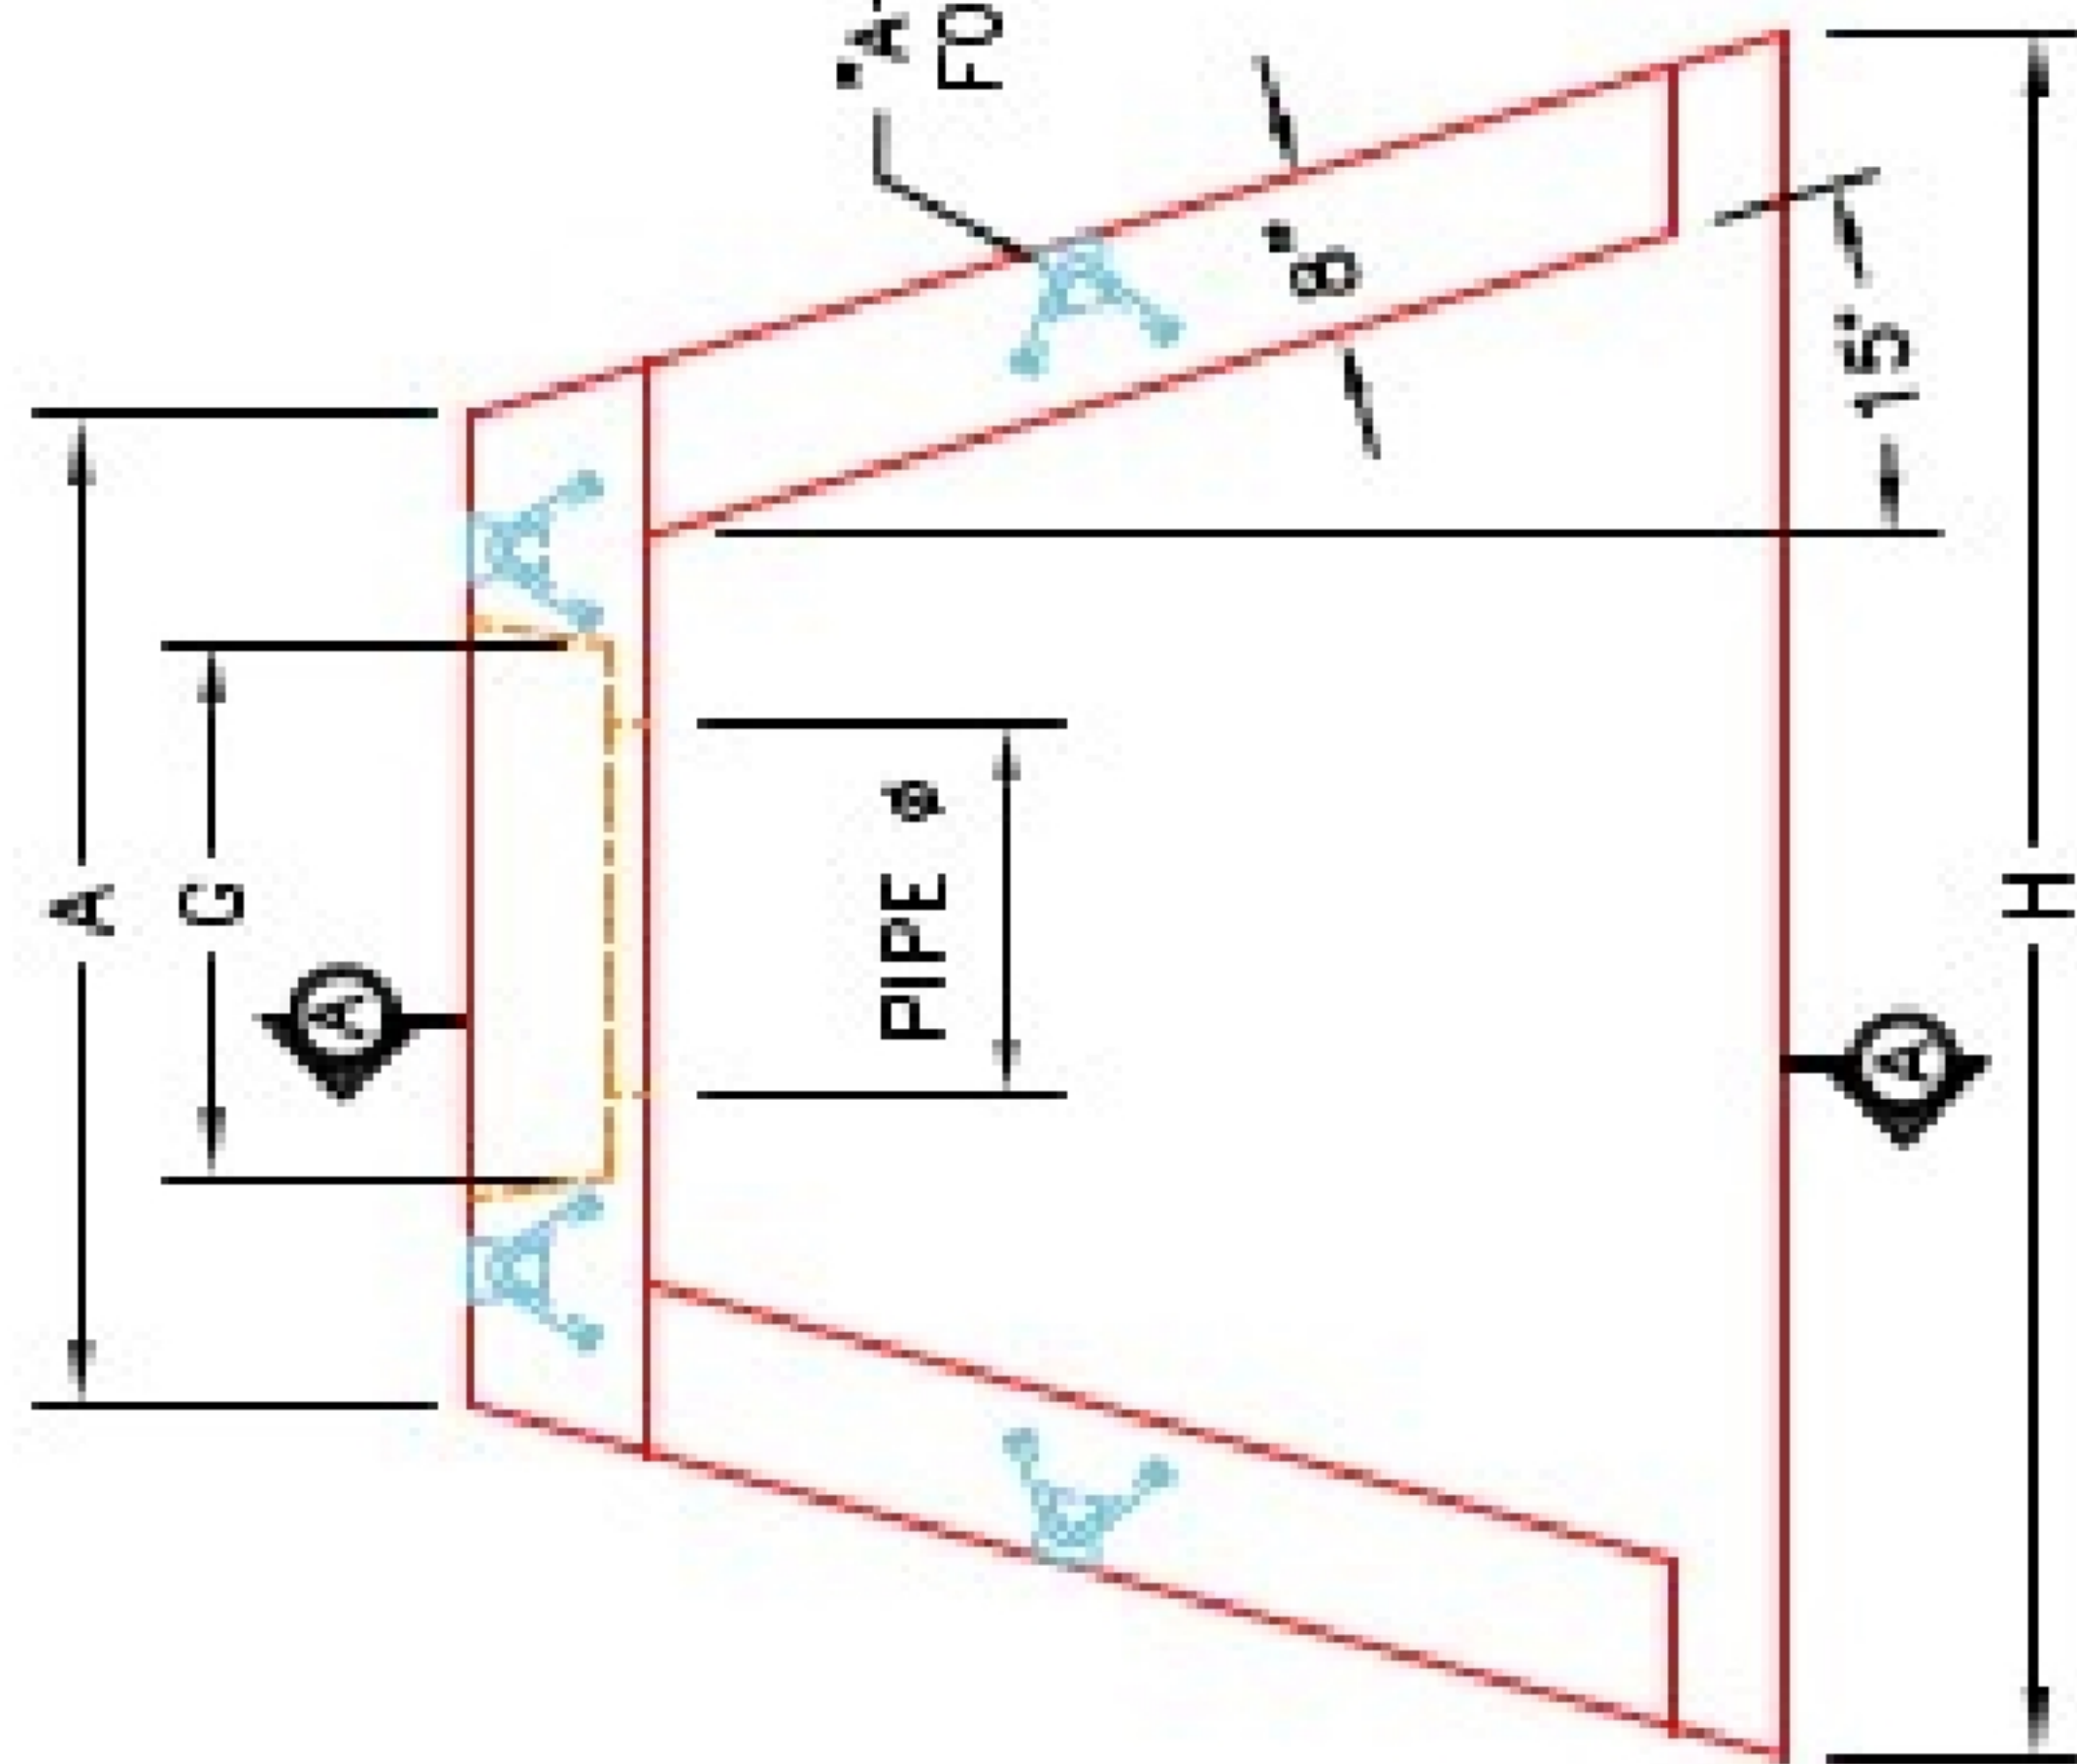


PLAN VIEW

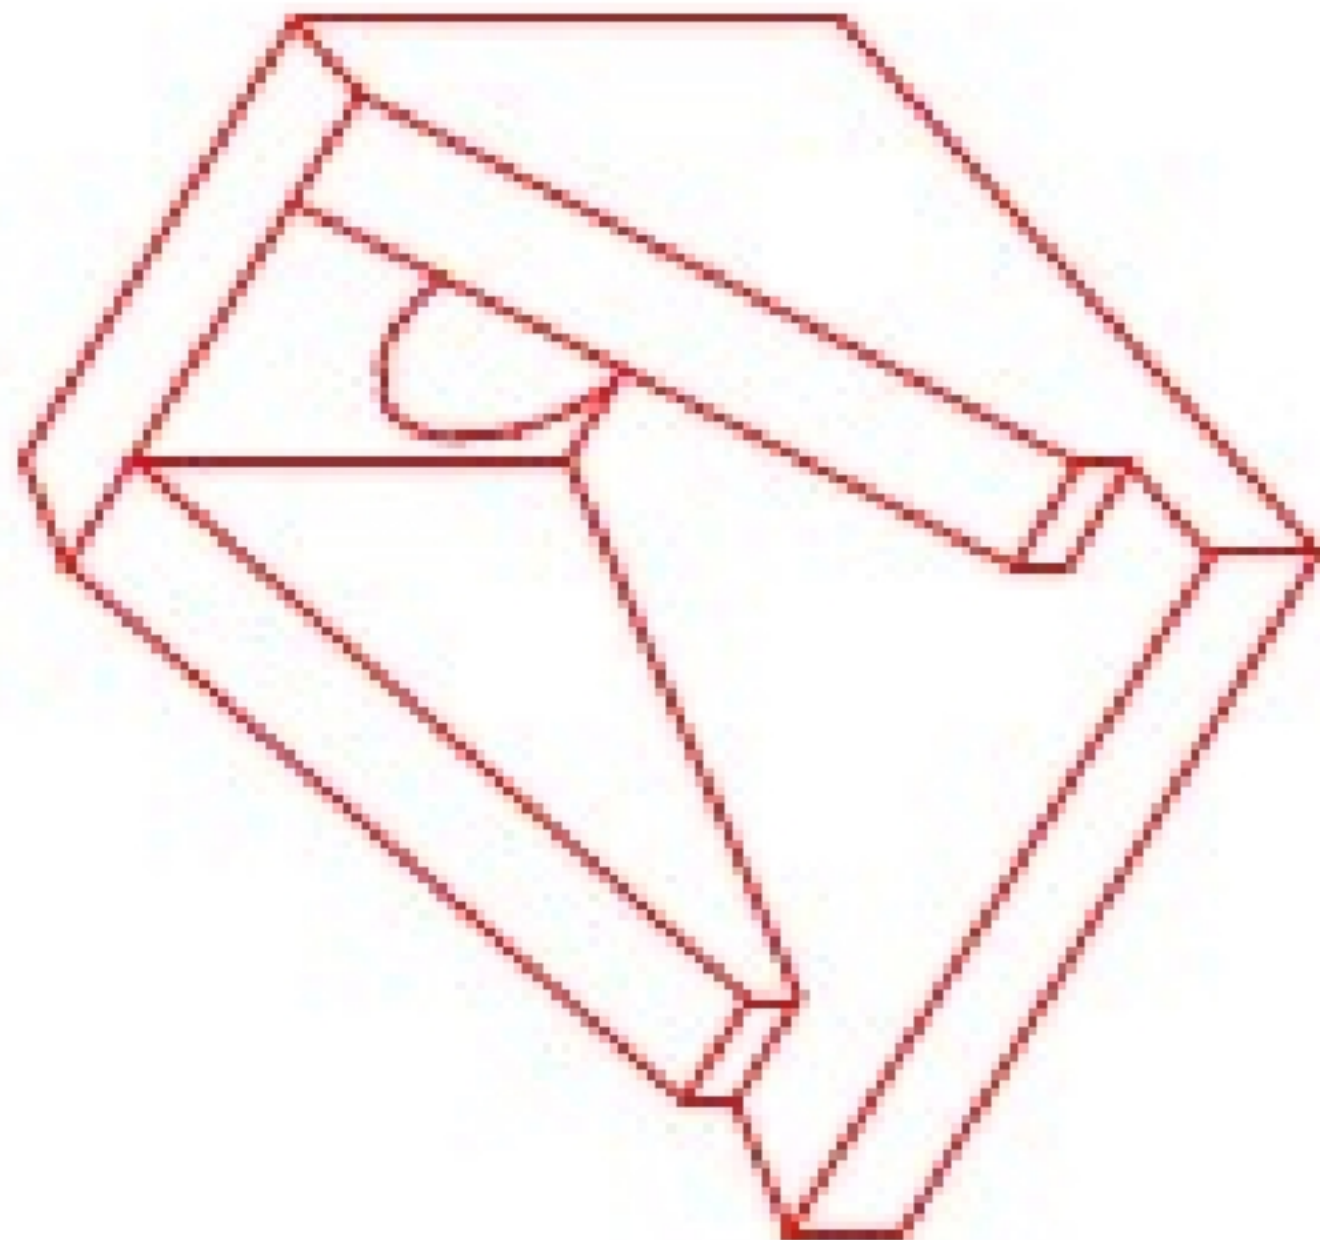

ISOMETRIC VIEW

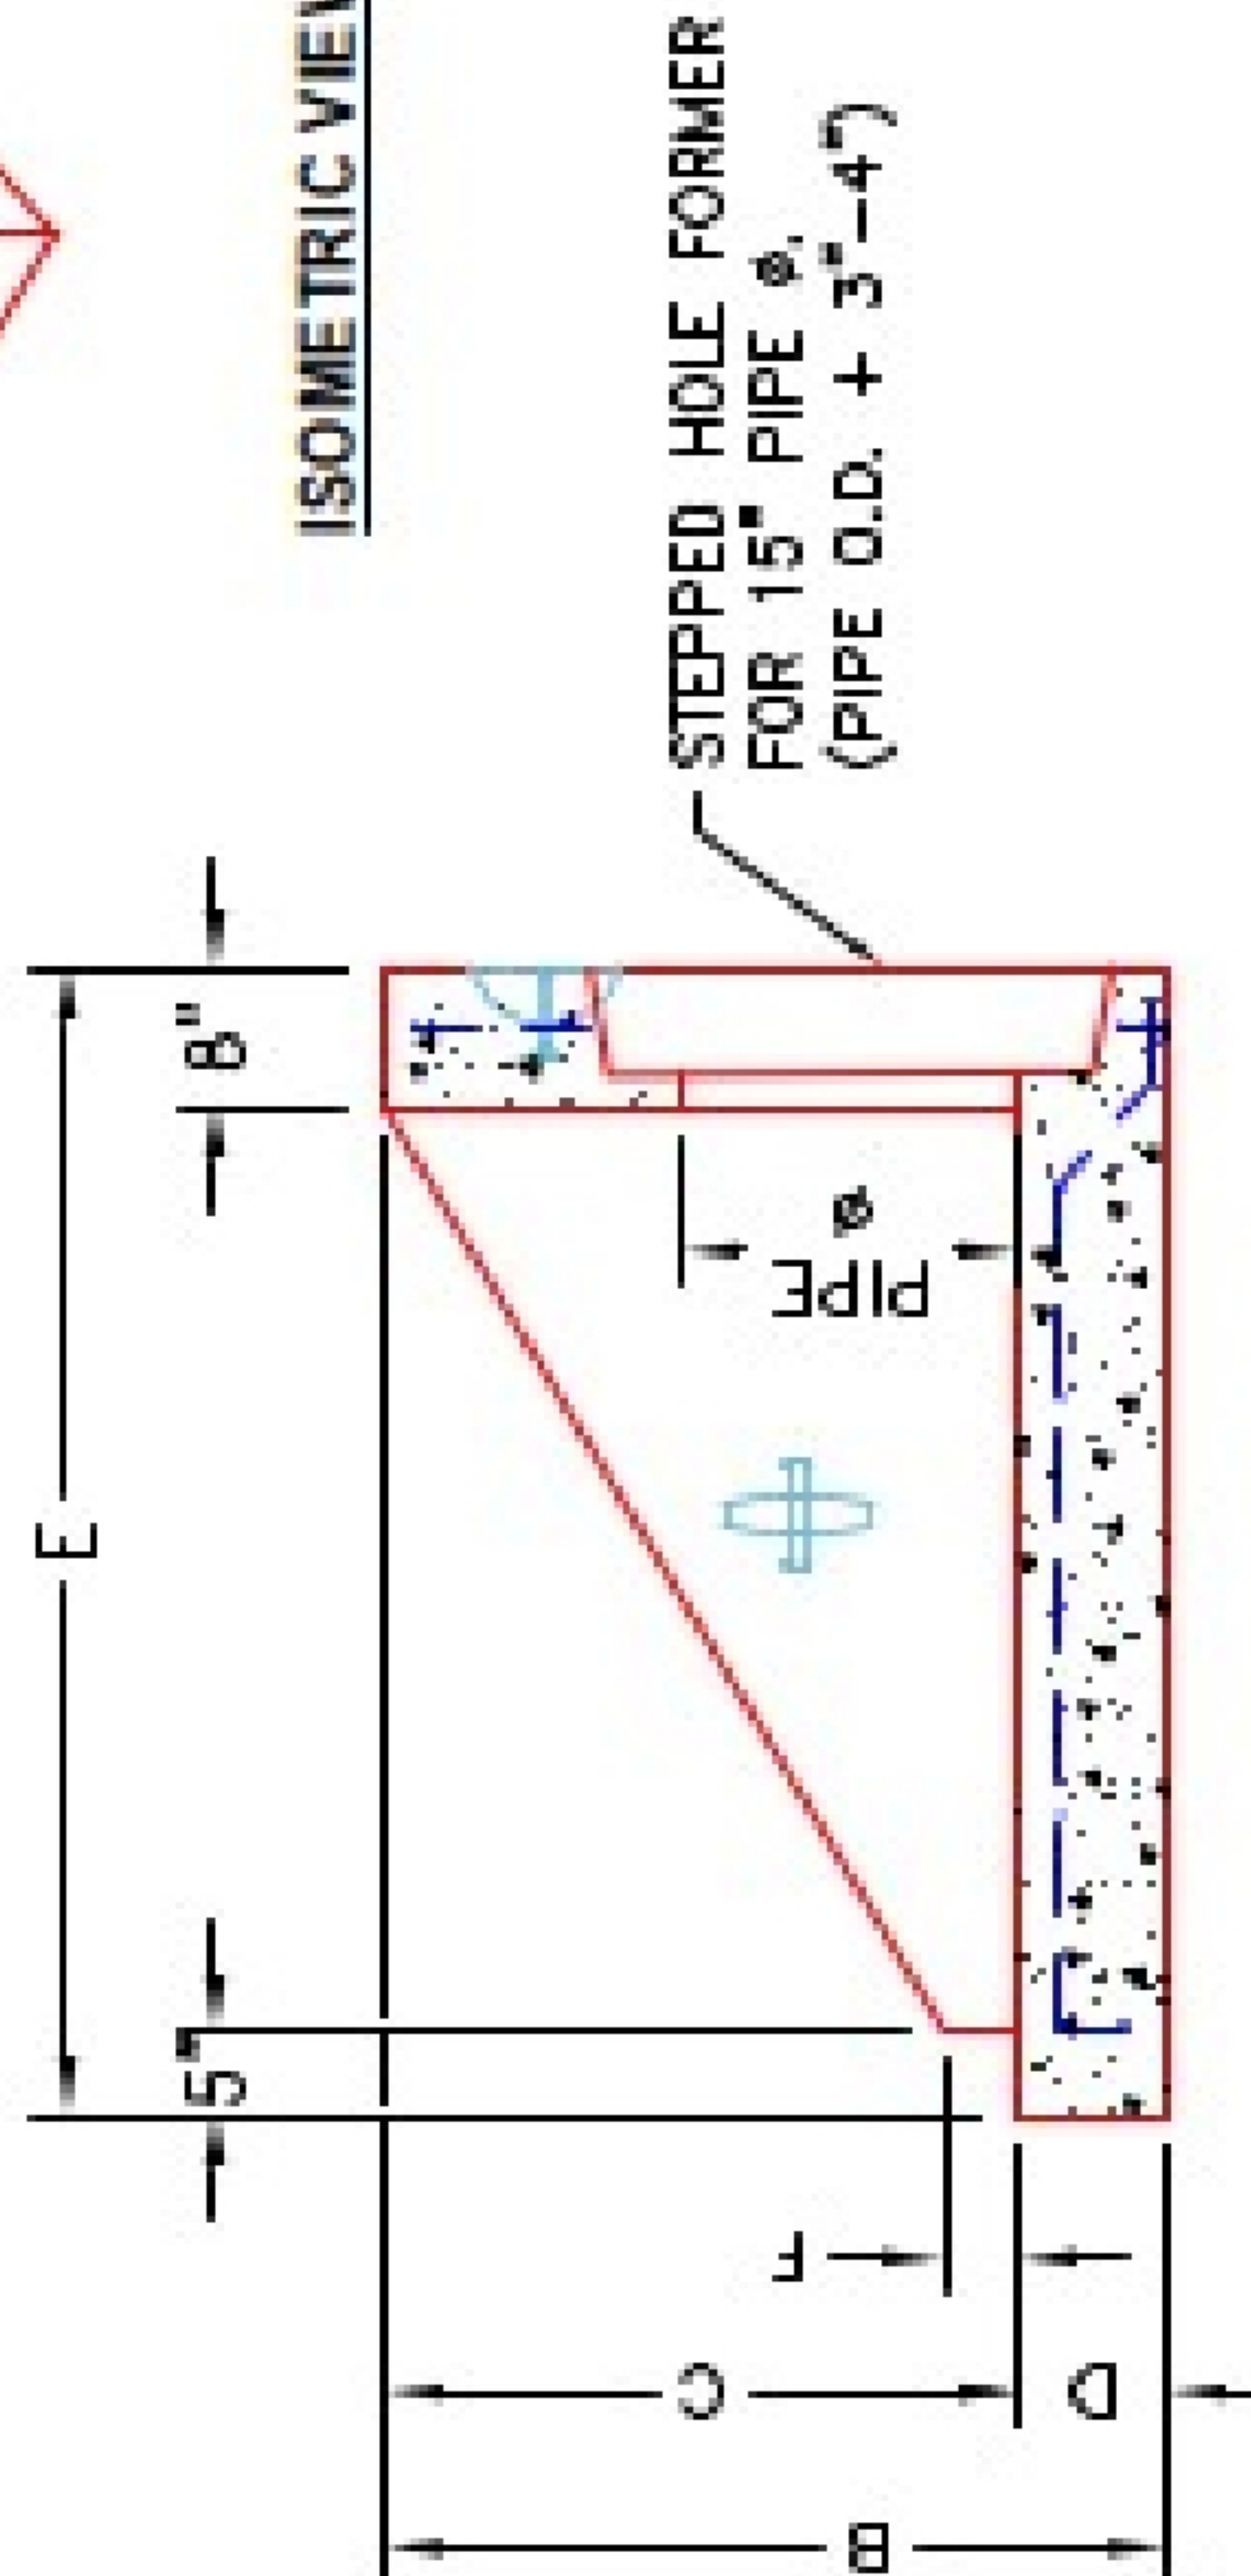

SECTION A-A

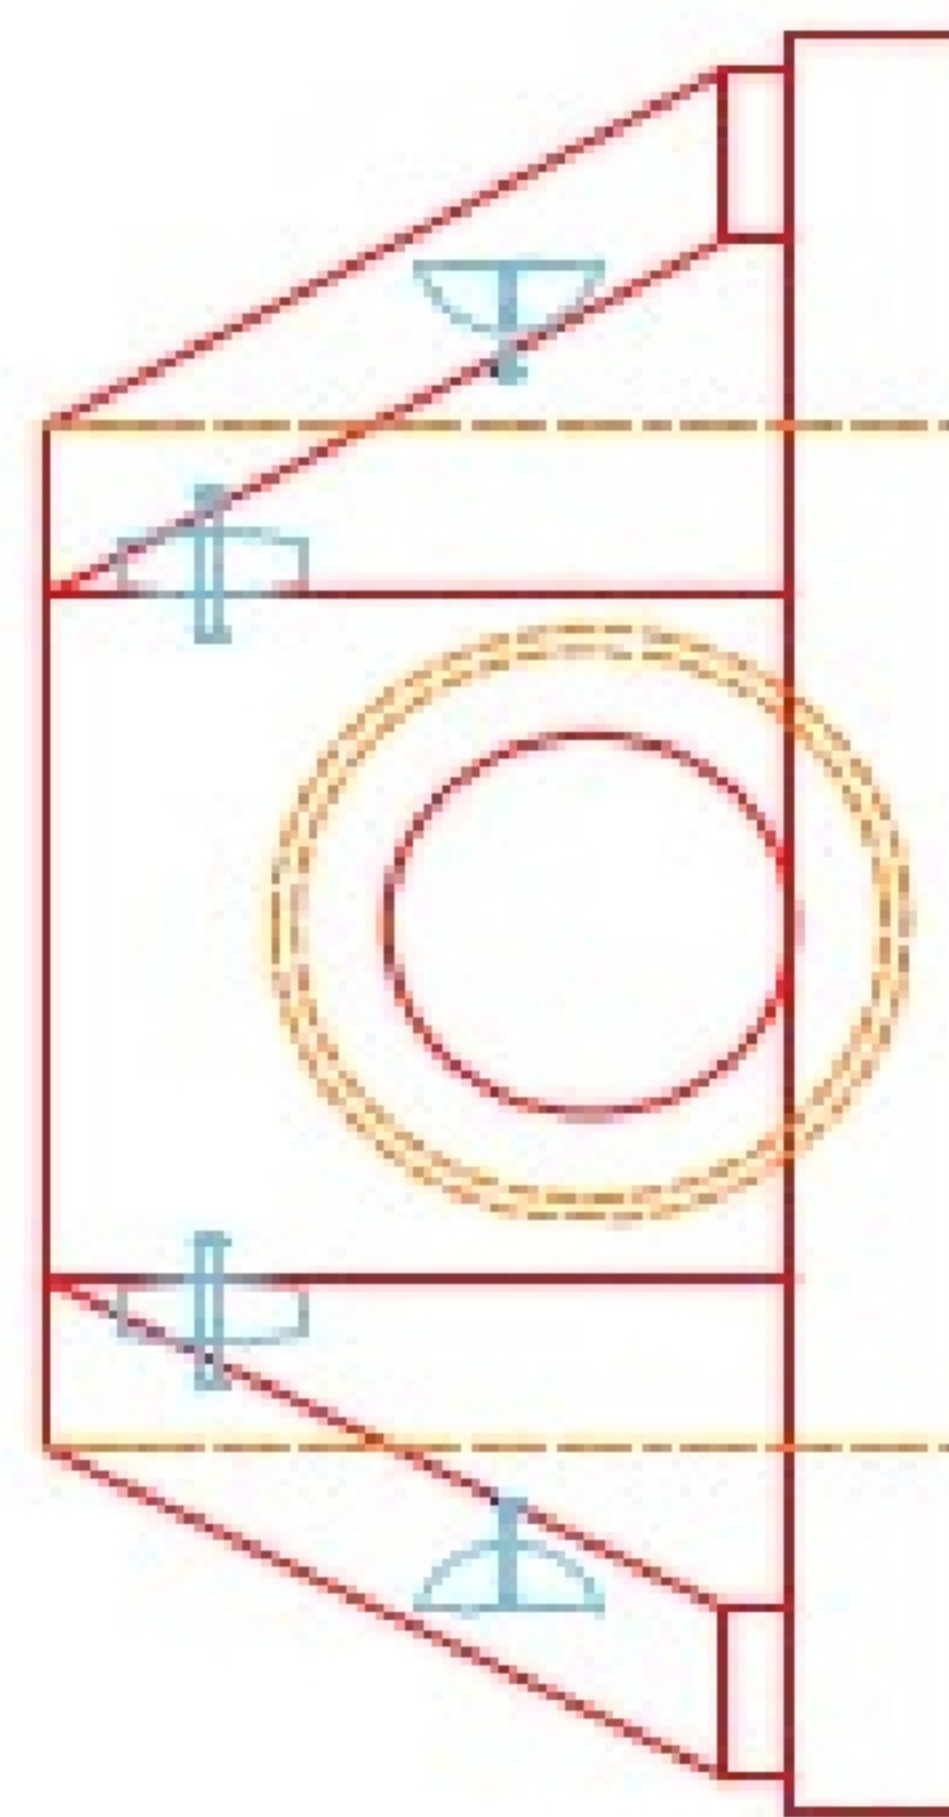

FRONT ELEVATION

NOTES:

1. CONCRETE: KYTC APPROVED.
2. REINFORCING: #4 BAR @ 12" C/C E.W.-GRADE 60, (WITH 2" CONCRETE COVER MINIMUM)
3. REINFORCING BARS TO BE TACK WELDED OR TIED.
4. PIPE AND LIFTING ANCHOR POCKETS TO BE GROUTED WITH KYTC APPROVED NON-SHRINK GROUT.
5. DRAWING TO BE USED IN CONJUNCTION WITH KYTC STD. DRAWING RDH-020-03 AND THE STANDARD SPECIFICATIONS FOR ROAD AND BRIDGE CONSTRUCTION.
6. 3/8" CHAMFER ON ALL EXPOSED EDGES.
7. PREFORMED STEPPED HOLE SIZED AS PER O.D. OF PIPE + 3"-4".



INFRASTRUCTURE PRECAST, INC.
581 WEST 7TH ST., BEAVER DAM, KY 40001
PHONE: (270) 363-2238, FAX: (270) 288-7624

KYTC 15" SLOPED & FLARED HEADWALL
w/ FLAT BOTTOM

DRAWING NO. HWSF15F DATE: 8-23-25
DESIGNED BY: J.L. ROSS, P.E. DRAWN BY: A. CORTEZ
WEB: WWW.ISPCAST.COM SCALE: NTS