

Job Name: 26-2648 Midtown Commons Apartments
Job Location: Madisonville, KY
Contractor: Steve Pleasant Excavating

Plant: Beaver Dam
7/20/2026 10:47:38 AM

Tech: S. Felletter
PC:




Structure ID: 3 HW


P1 HWPC30

30" - PIPE CULVERT HEADWALL F/F


DIMENSIONS									
PRE #	A	B	C	D	E	F	G	H	WEIGHT
30"	4'-0"	6'-0"	4'-0"	1'-0"	5'-0"	1'-0"	1'-0"	3'-0"	0,000 lbs.
36"	4'-0"	6'-0"	4'-0"	1'-0"	5'-0"	1'-0"	1'-0"	3'-0"	0,000 lbs.
42"	6'-0"	6'-0"	5'-0"	2'-0"	6'-0"	1'-0"	1'-0"	4'-0"	10,000 lbs.
48"	6'-0"	6'-0"	5'-0"	2'-0"	6'-0"	1'-0"	1'-0"	4'-0"	10,000 lbs.
54"	7'-0"	7'-0"	6'-0"	2'-0"	7'-0"	1'-0"	1'-0"	5'-0"	10,000 lbs.
60"	7'-0"	7'-0"	6'-0"	2'-0"	7'-0"	1'-0"	1'-0"	5'-0"	10,000 lbs.

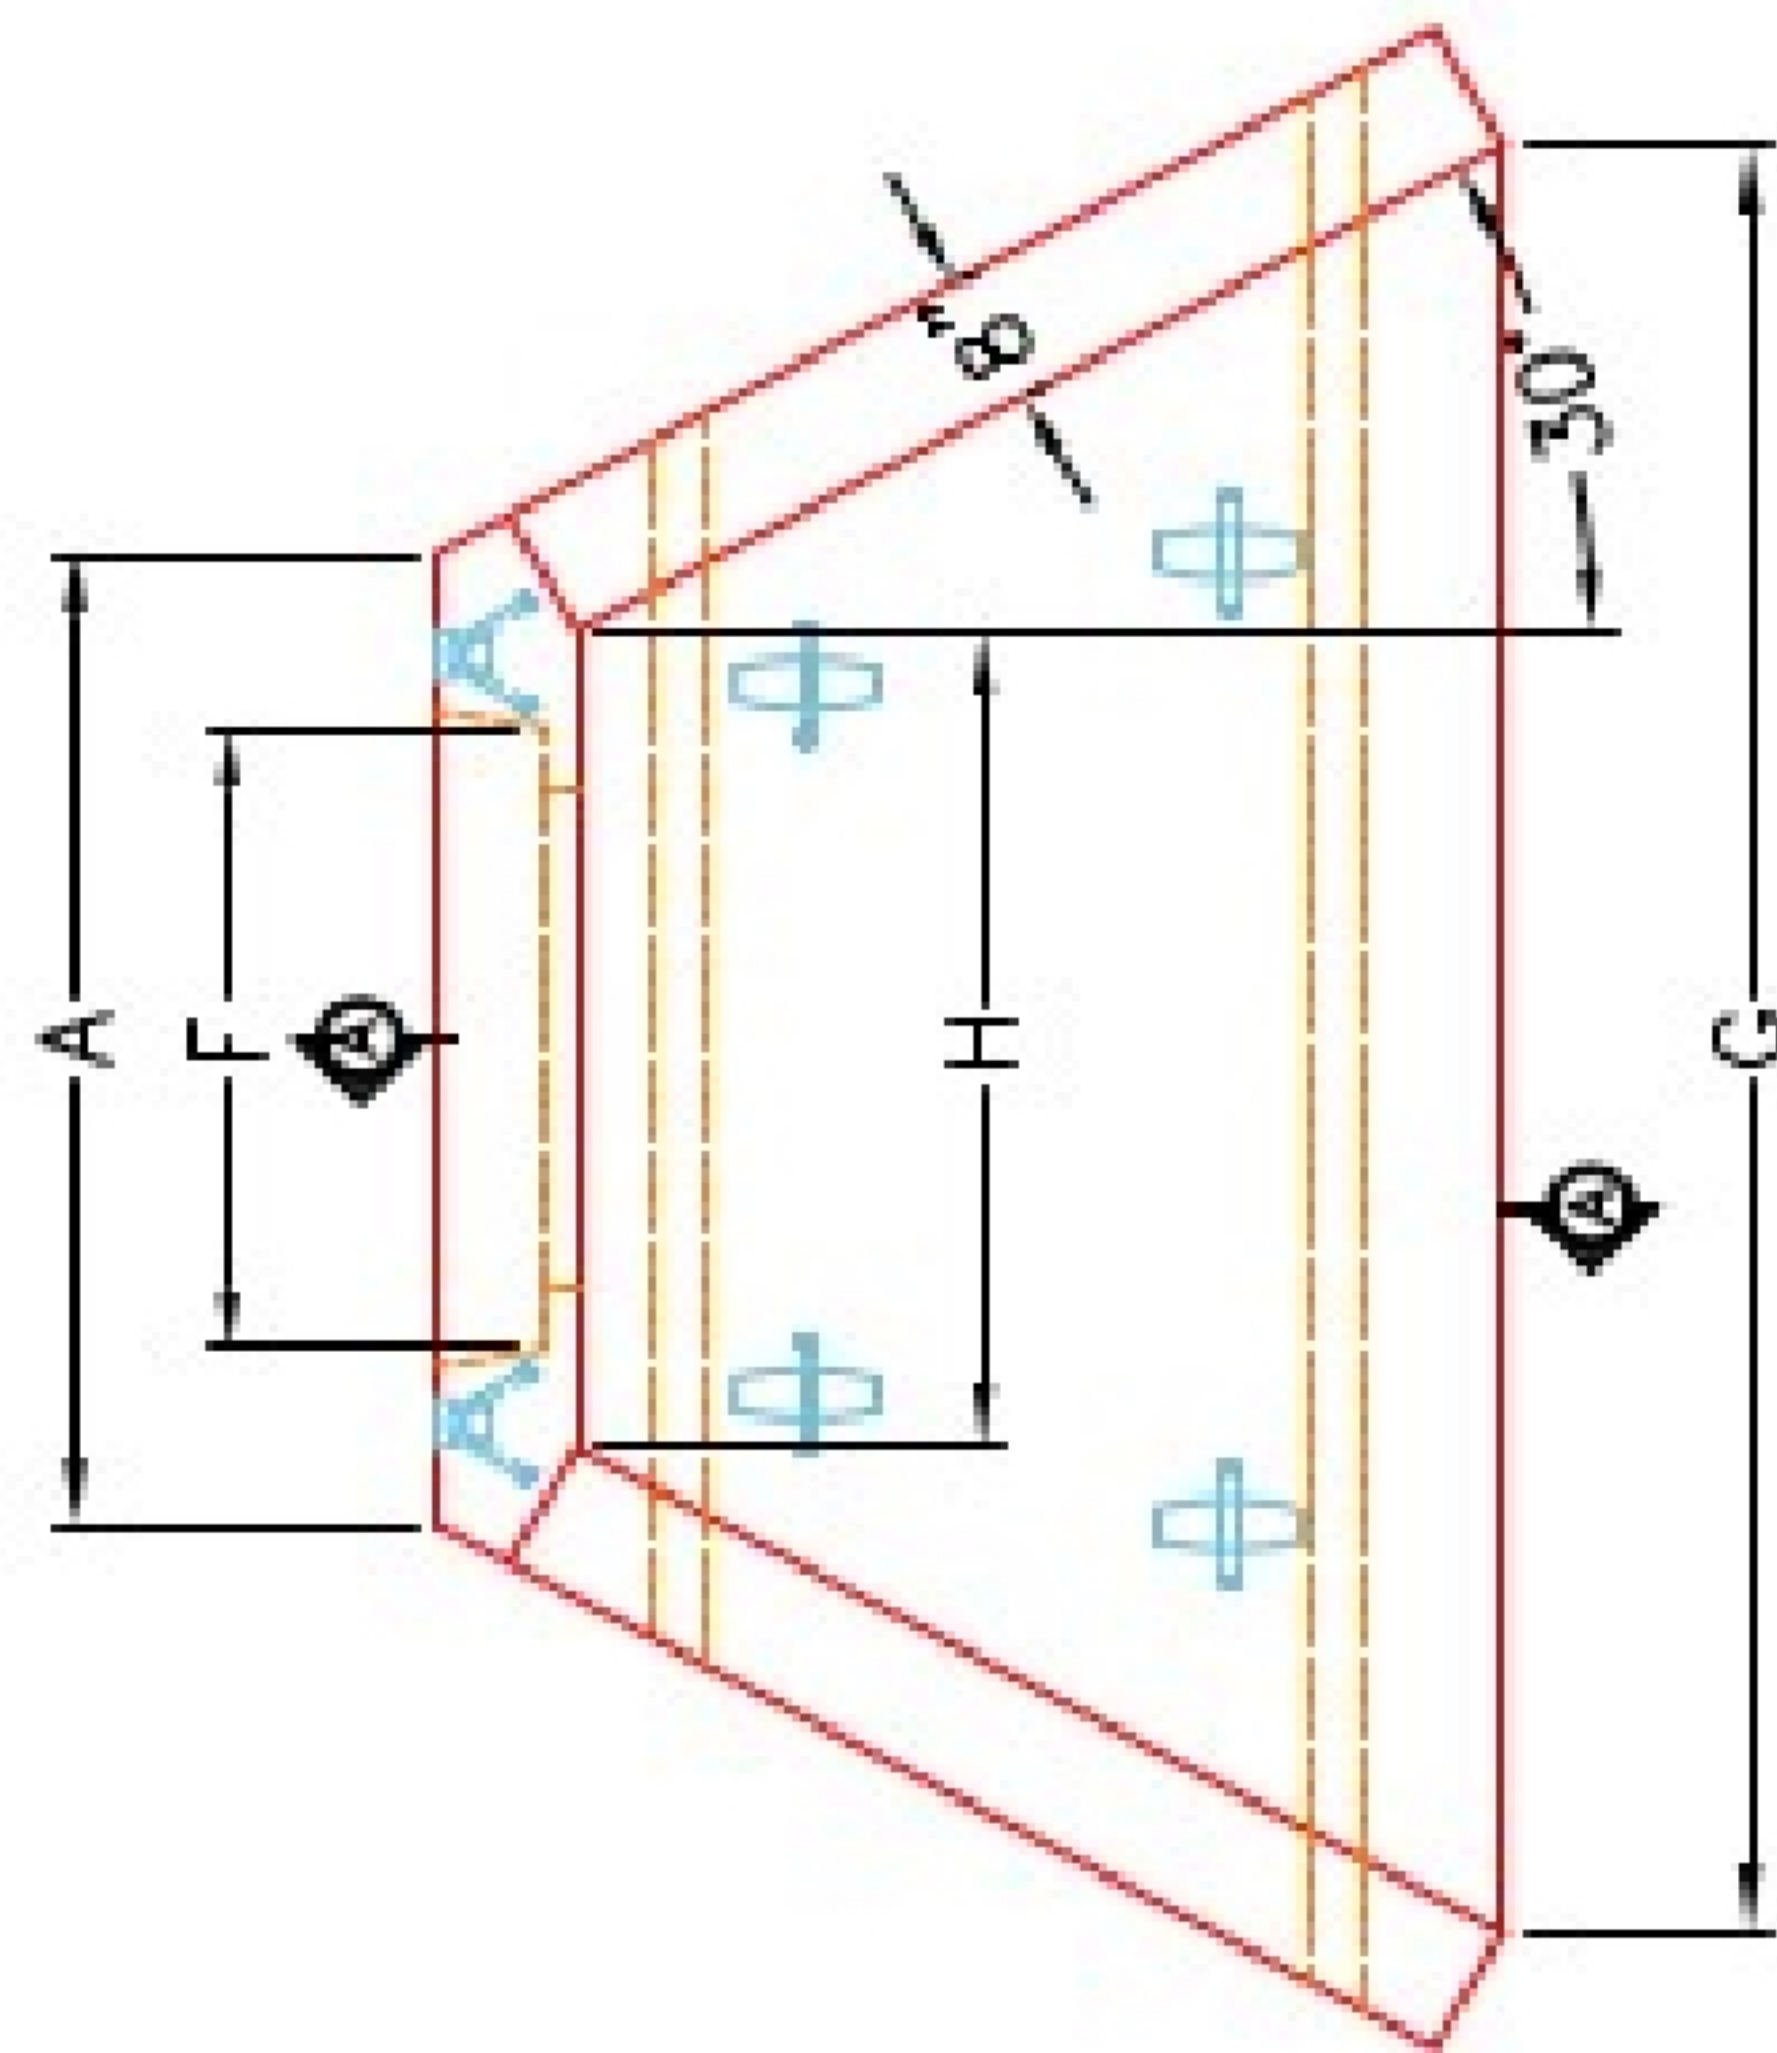

PLAN VIEW

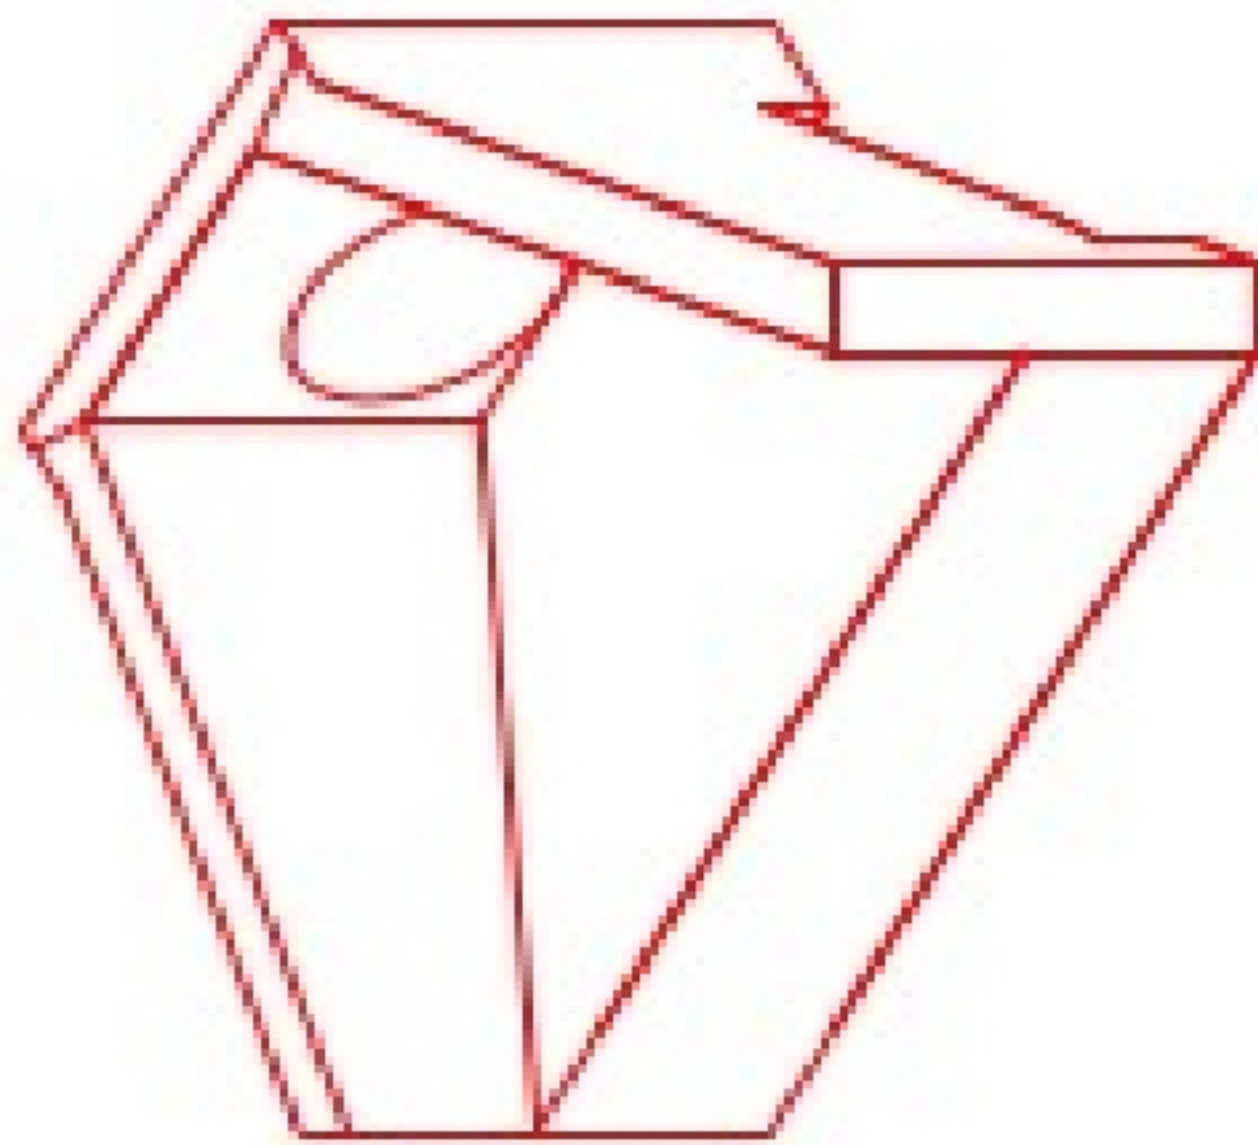


ISOMETRIC VIEW

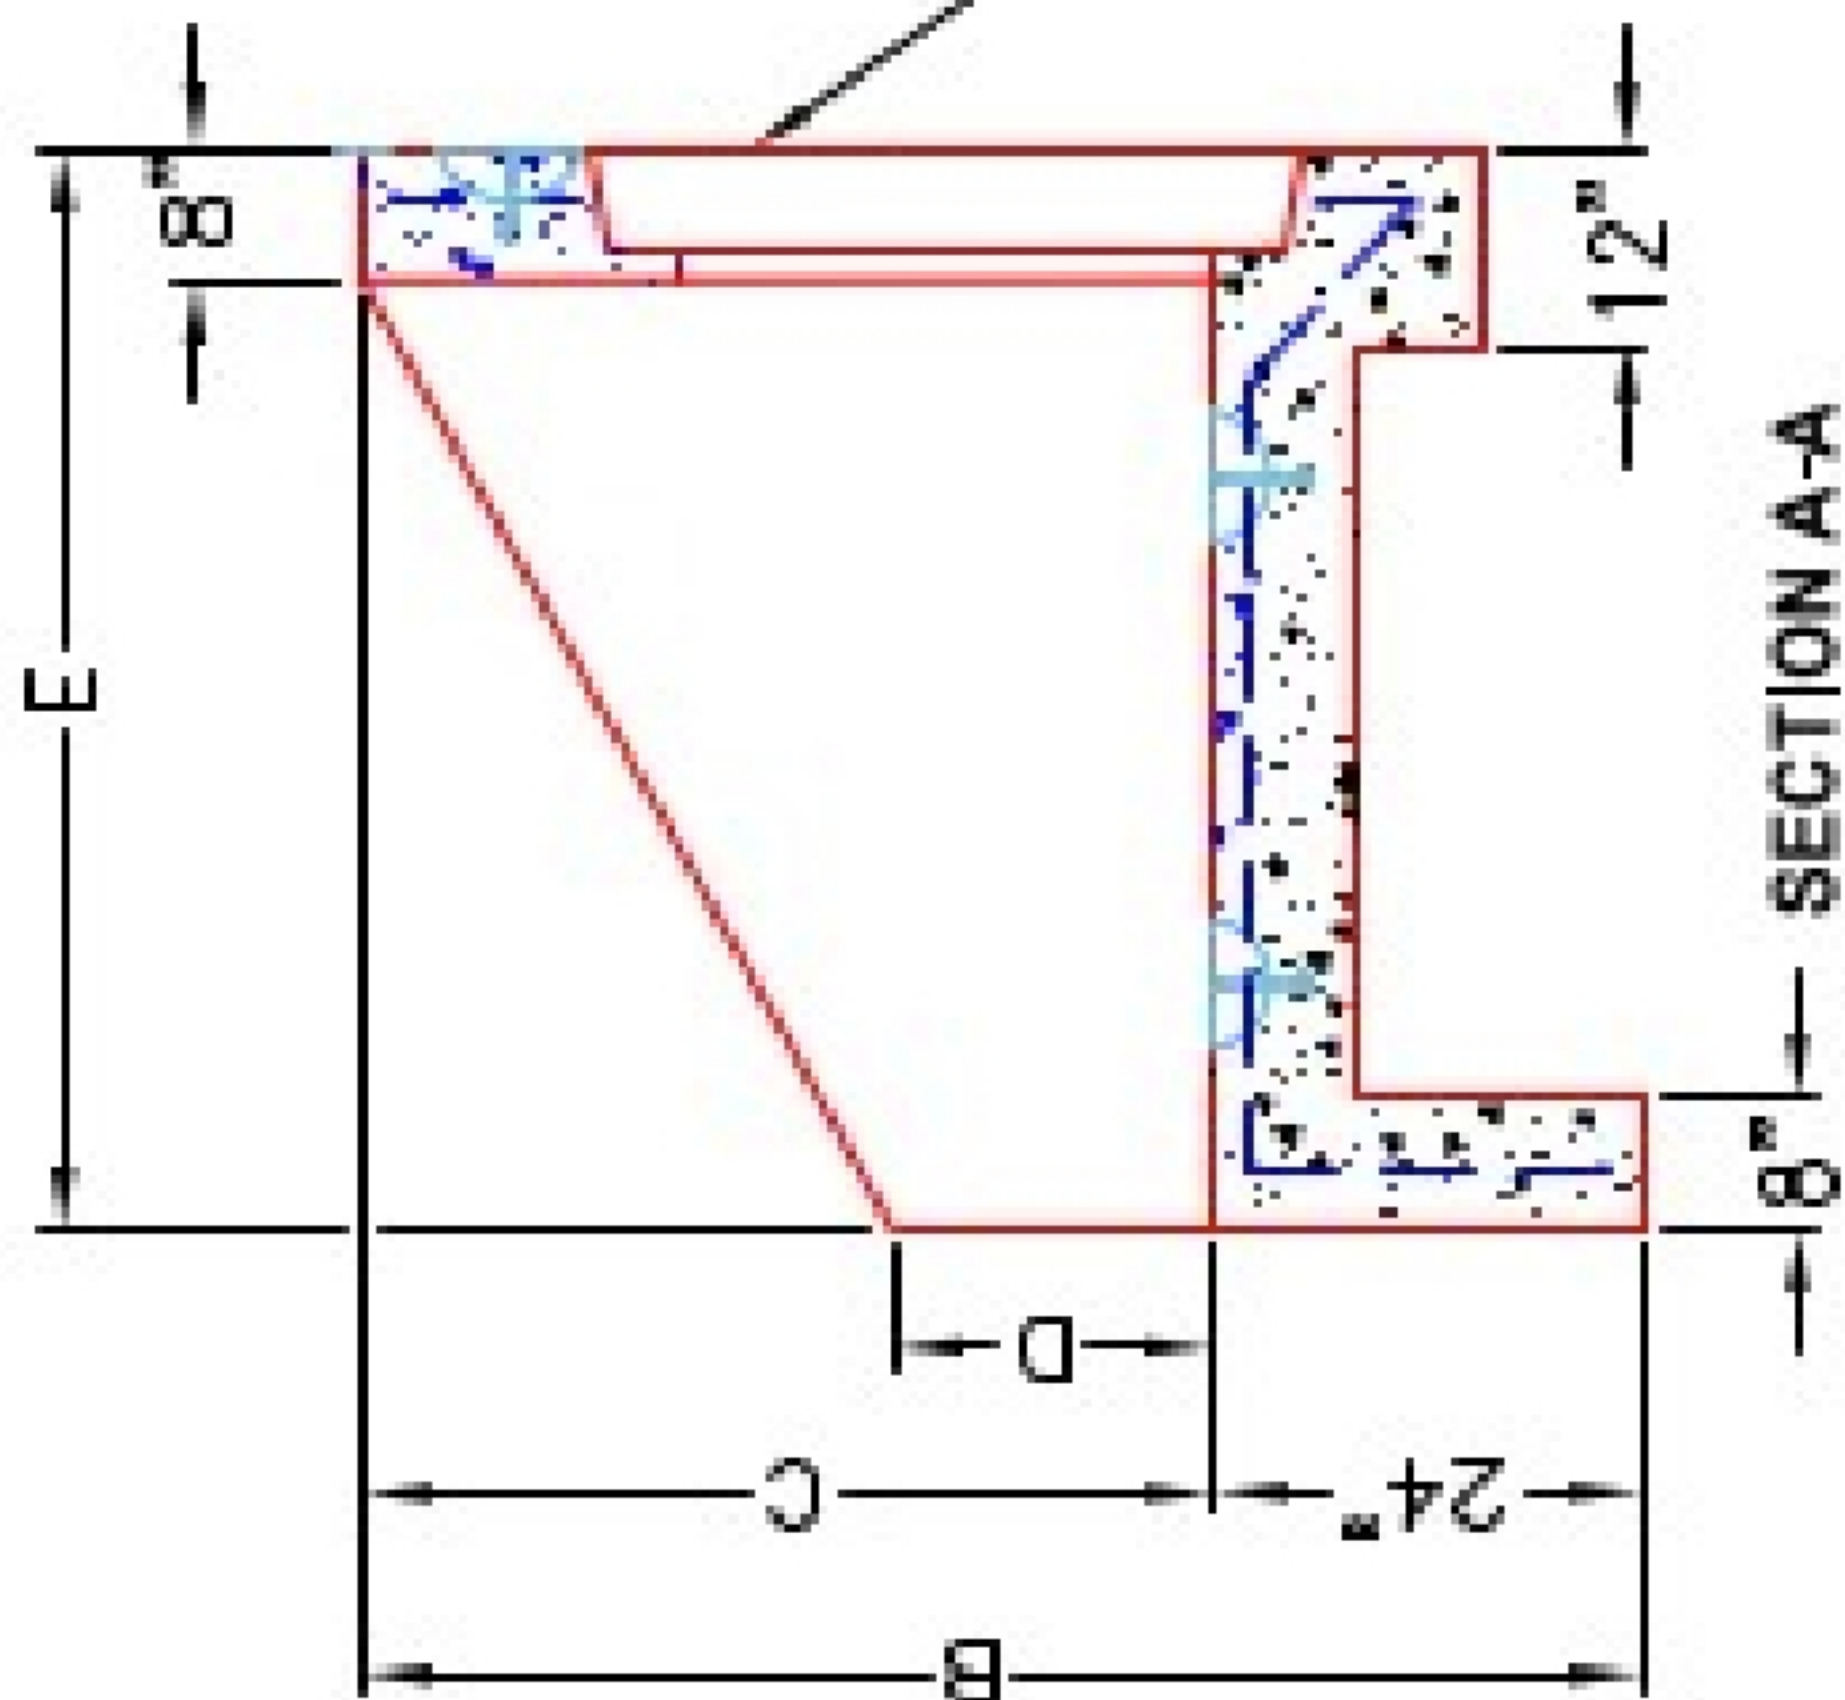

FRONT ELEVATION

"A-ANCHOR" LIFTING SYSTEM FOR PLANT & FIELD HANDLING.

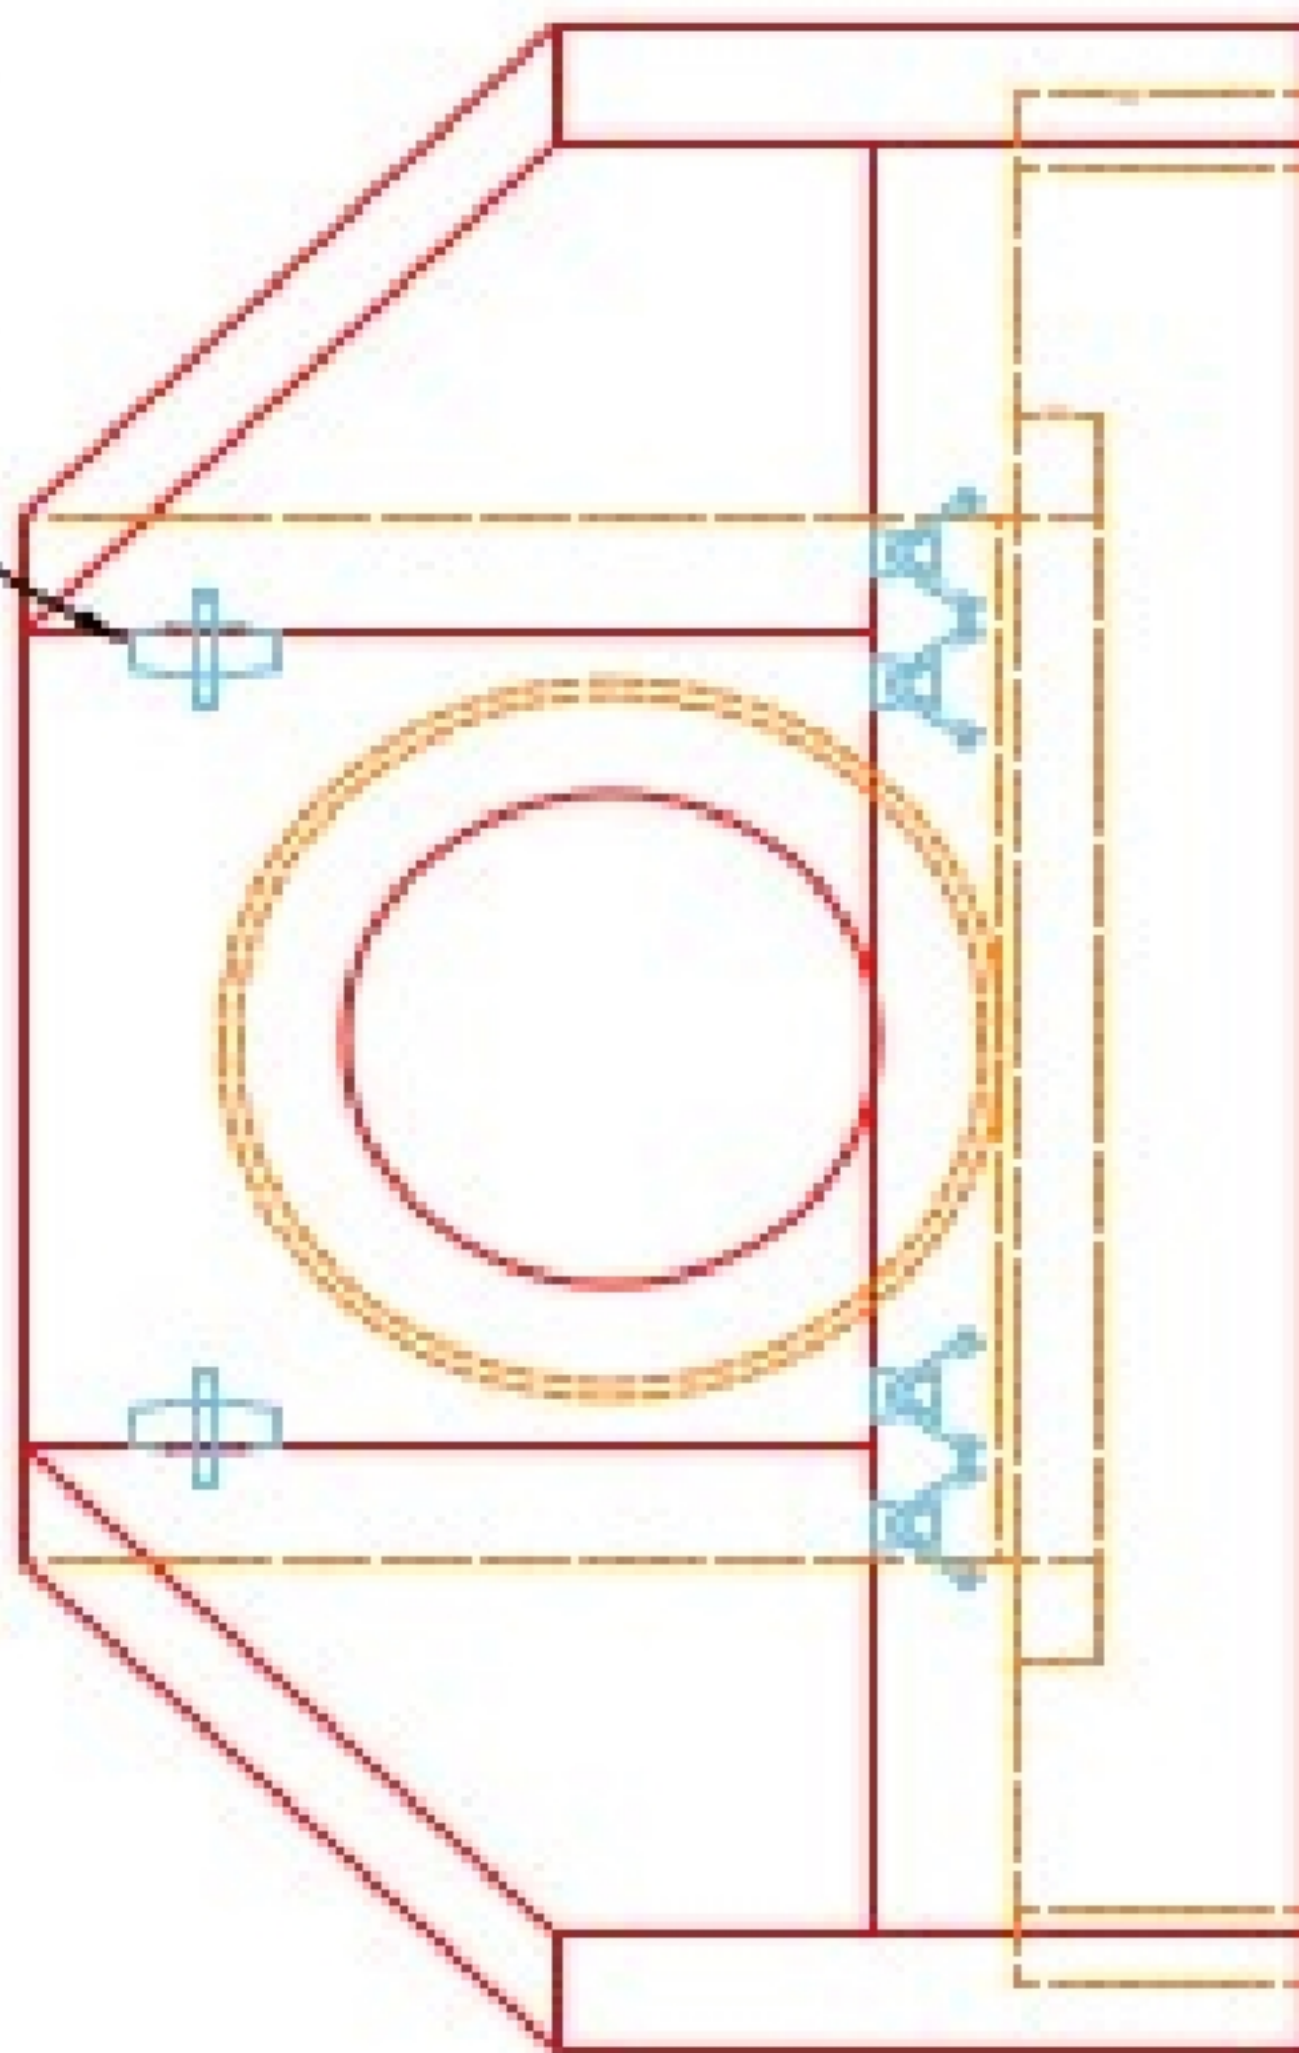

NOTES:

1. CONCRETE: KYTC APPROVED.
2. REINFORCING: #5 BAR @ 12" C/C E.W.-GRADE 60, (WITH 2" CONCRETE COVER MINIMUM)
3. REINFORCING BARS TO BE TACK WELDED OR TIED.
4. PIPE AND LIFTING ANCHOR POCKETS TO BE GROUTED WITH KYTC APPROVED NON-SHRINK GROUT.
5. DRAWING TO BE USED IN CONJUNCTION WITH KYTC STD. DRAWING RDH-110-02, RDH-210-03 AND THE STANDARD SPECIFICATIONS FOR ROAD AND BRIDGE CONSTRUCTION.
6. 3" CHAMFER ON ALL EXPOSED EDGES.
7. PREFORMED STEPPED HOLE SIZED AS PER O.D. OF PIPE + 3"-4".

APPROVED FOR DESIGN ONLY

APPROVED
AS PER SPECIFICATION 100.02
DATE: 1/20/2021 9:50 am
BY: [Signature]
KYTC DIV. OF CONSTRUCTION

INFRASTRUCTURE PRECAST, INC.
601 WEST 7TH ST., BEAVER DAM, KY, 40009
PHONE (502) 338-2222, FAX (502) 338-2224

INFRASTRUCTURE PRECAST, INC.
601 WEST 7TH ST., BEAVER DAM, KY, 40009
PHONE (502) 338-2222, FAX (502) 338-2224

DATE: 12-14-20
DRAWN BY: J.H. ROSS, PE
CHECKED BY: J.H. ROSS, PE
SCALE: NTS